

# Pattarapon Worasiri

97/1, Itsaraphap Road, Wat Mai Phiren, Bangkok Yai,

Bangkok, 10600

Mobile: 0813465111

E-mail: [pattarapon.poon17@gmail.com](mailto:pattarapon.poon17@gmail.com)



---

## Career Objective

I have the intention to bring the knowledge that I have studied mechanical engineering. used to make Ready to study and learn new tasks in order to lead further in the various tasks that I have been assigned in order to achieve success in accordance with the policy and benefits to the company.

## Education

2015-2020: Bachelor's degree, Rajamankala University of Technology  
Rattanakosin, Salaya, Faculty of Engineering, Mechanical Engineering

## Relevant Work Experience

November 2019-February 2020: **Internship**, Esmac Asia Industry,  
Samutsakhon., Position: R&D and Engineering Industry.

March 2021-Curren: **Working**, True Energy Power plant, Nakhonpathom.,  
Position: Design Engineer

## Qualifications & Awards

February 2020: Certificate Production Engineer

## **Key Skills**


- Drawing 2D & 3D
- Prepare Detail Drawings, Shop Drawings, and BOQ.
- Control Production Line.

## **Technical Skills**


- 1.Can use the Program: Auto cad, Solid Work.
- 2.Can use the Program: Microsoft Word, Excel, Power point.

## **Interests**


- 1.Site Engineer.
- 2.Miantained Engineer.
- 3.Industry Engineer.
- 4.Design Engineer.

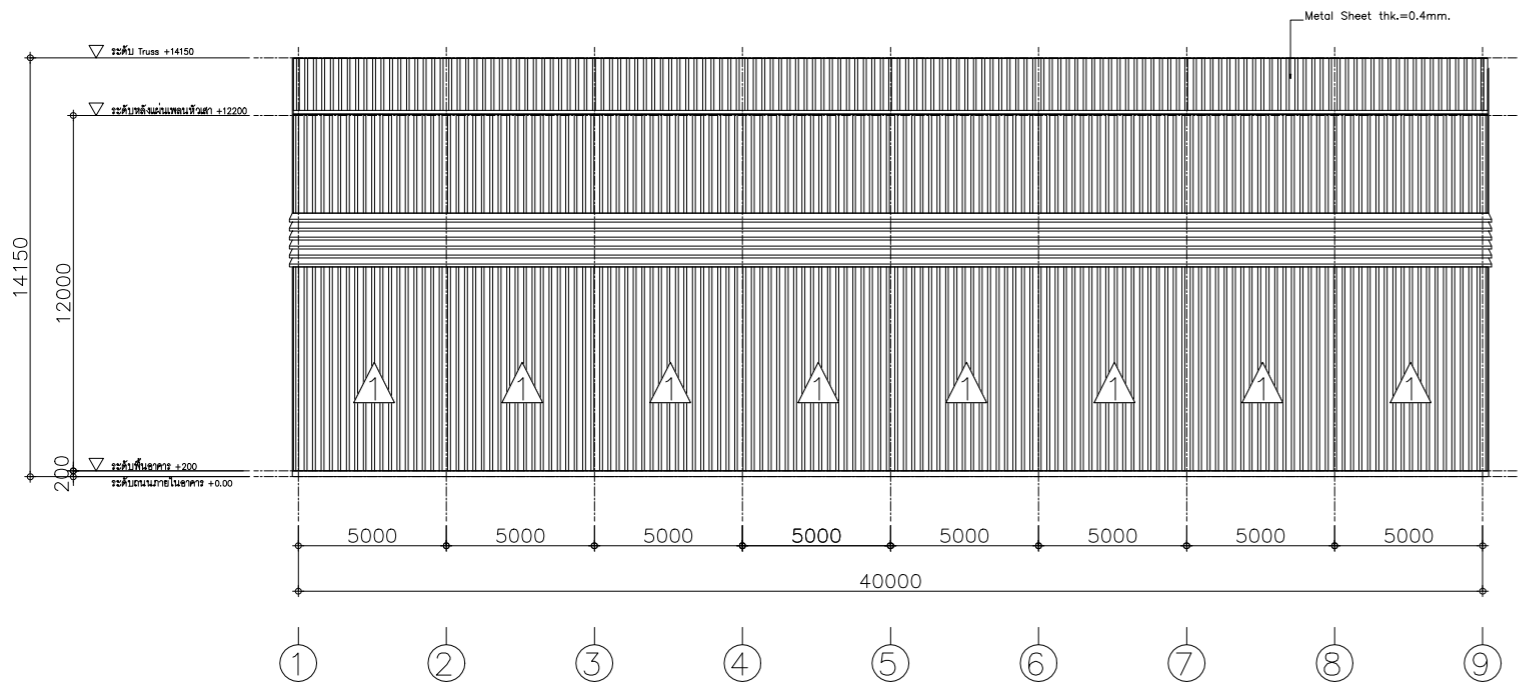


รูปด้าน 1  
 1/001 SCALE 1:300

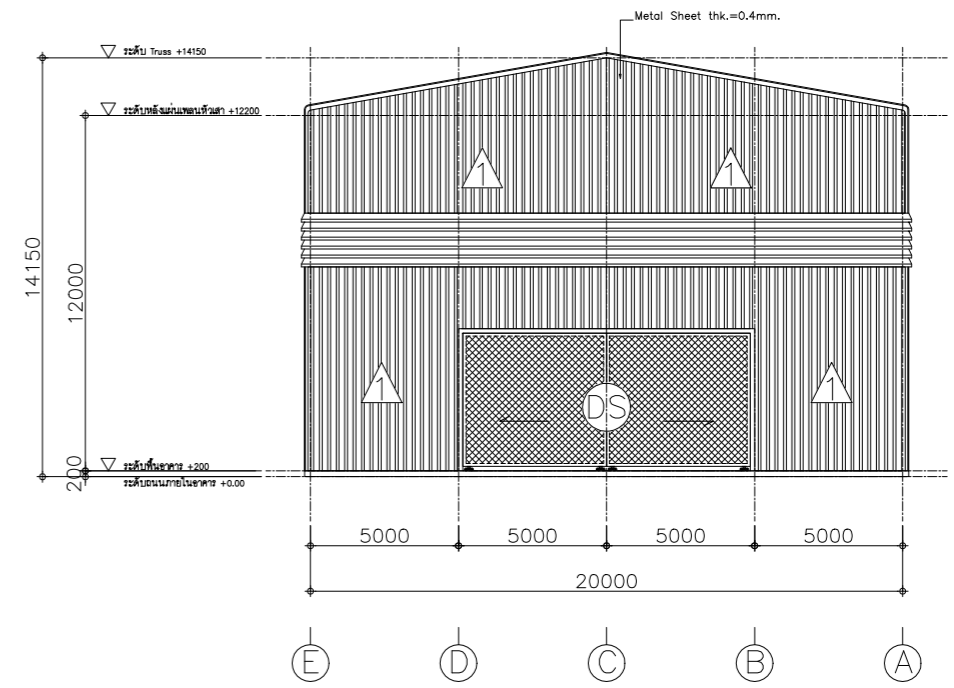

รูปด้าน 2  
 2/002 SCALE 1:300


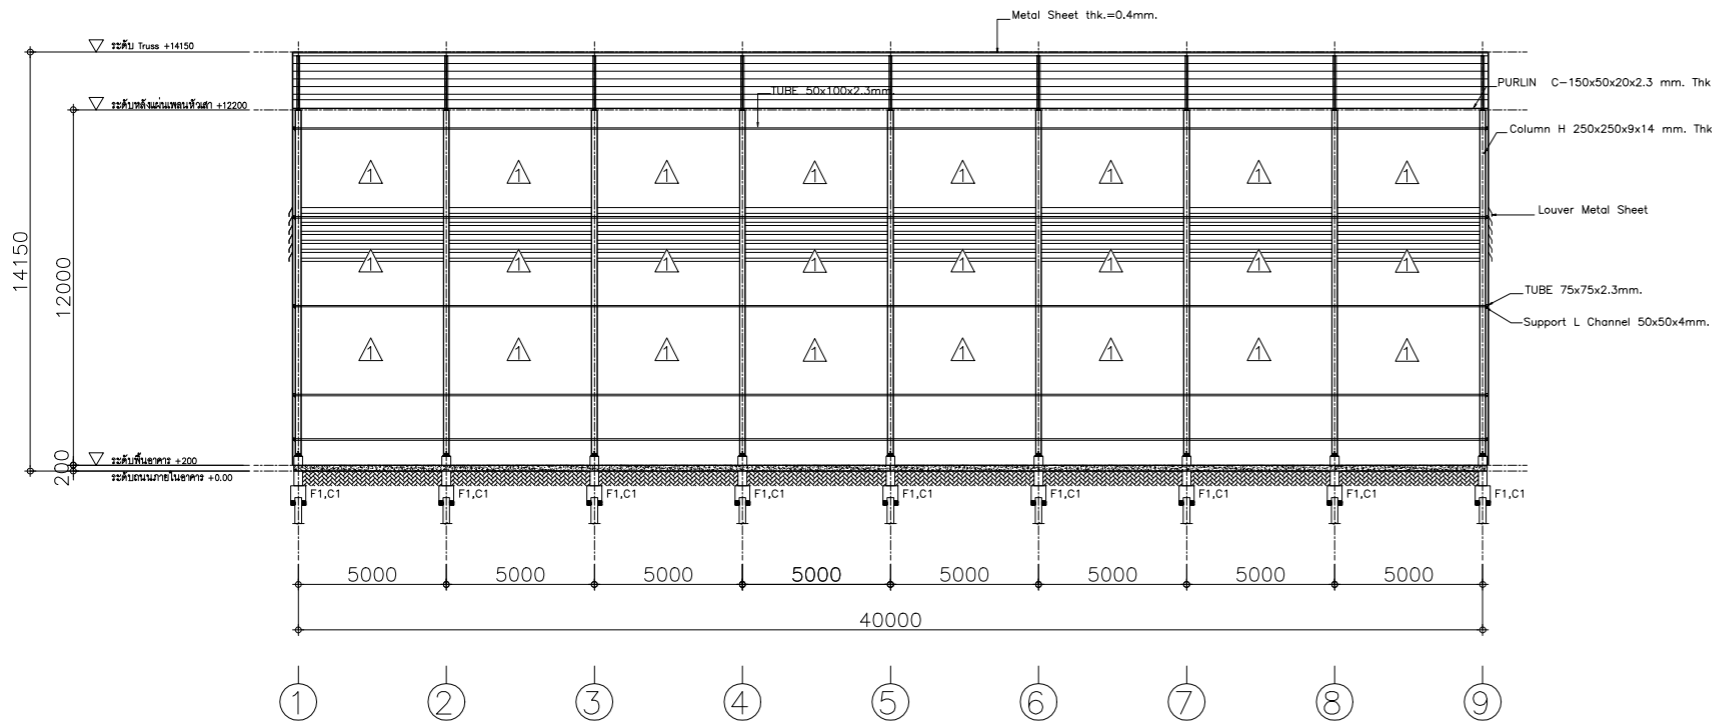


รูปตัด A-A  
 1/001 SCALE 1:300

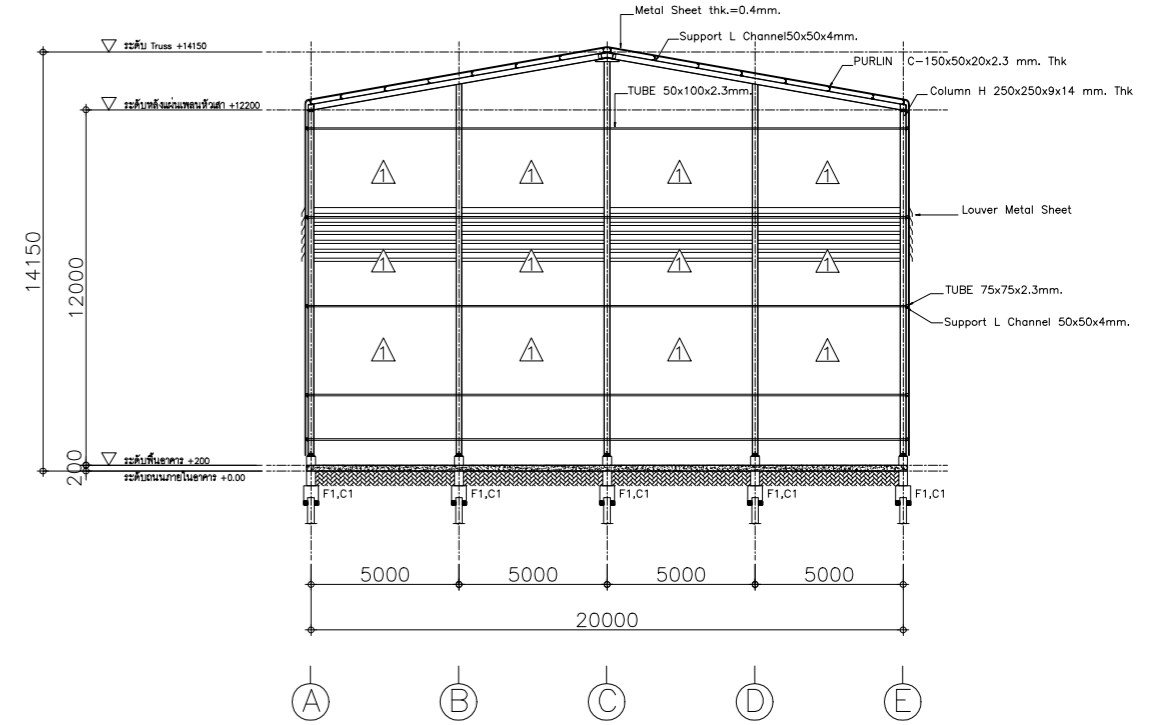

รูปตัด B-B  
 2/002 SCALE 1:300

ตัวอย่างผลงานการออกแบบ อาคารโกดัง

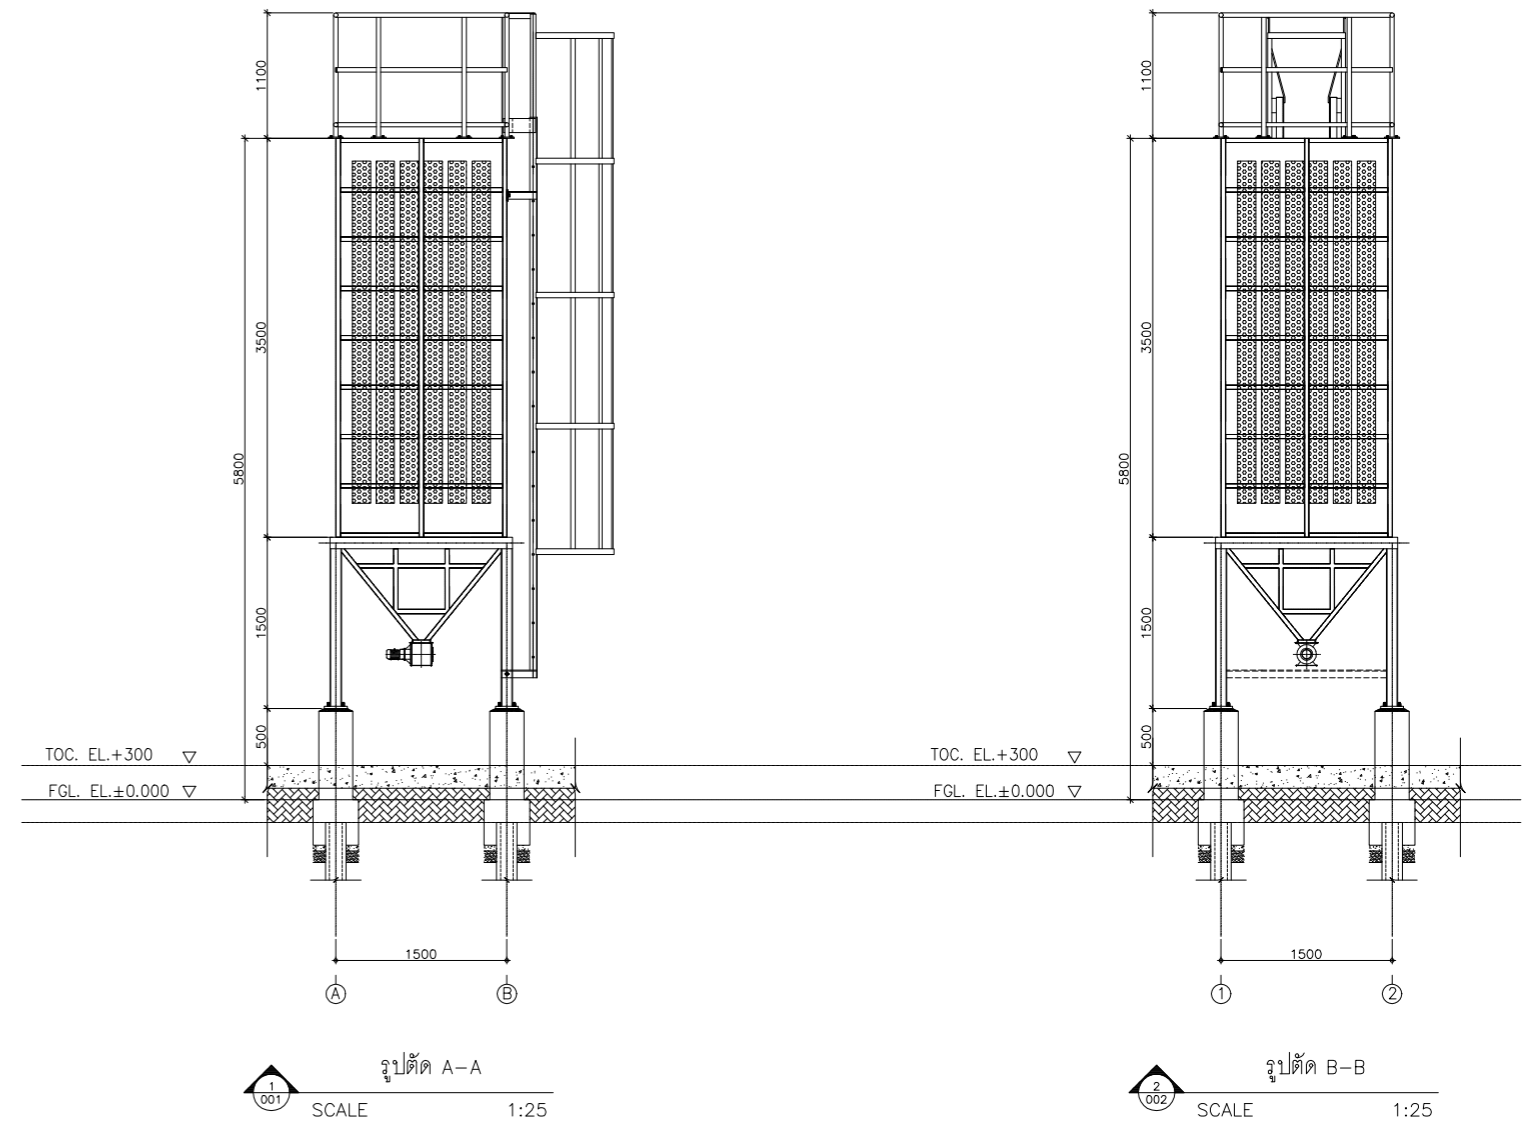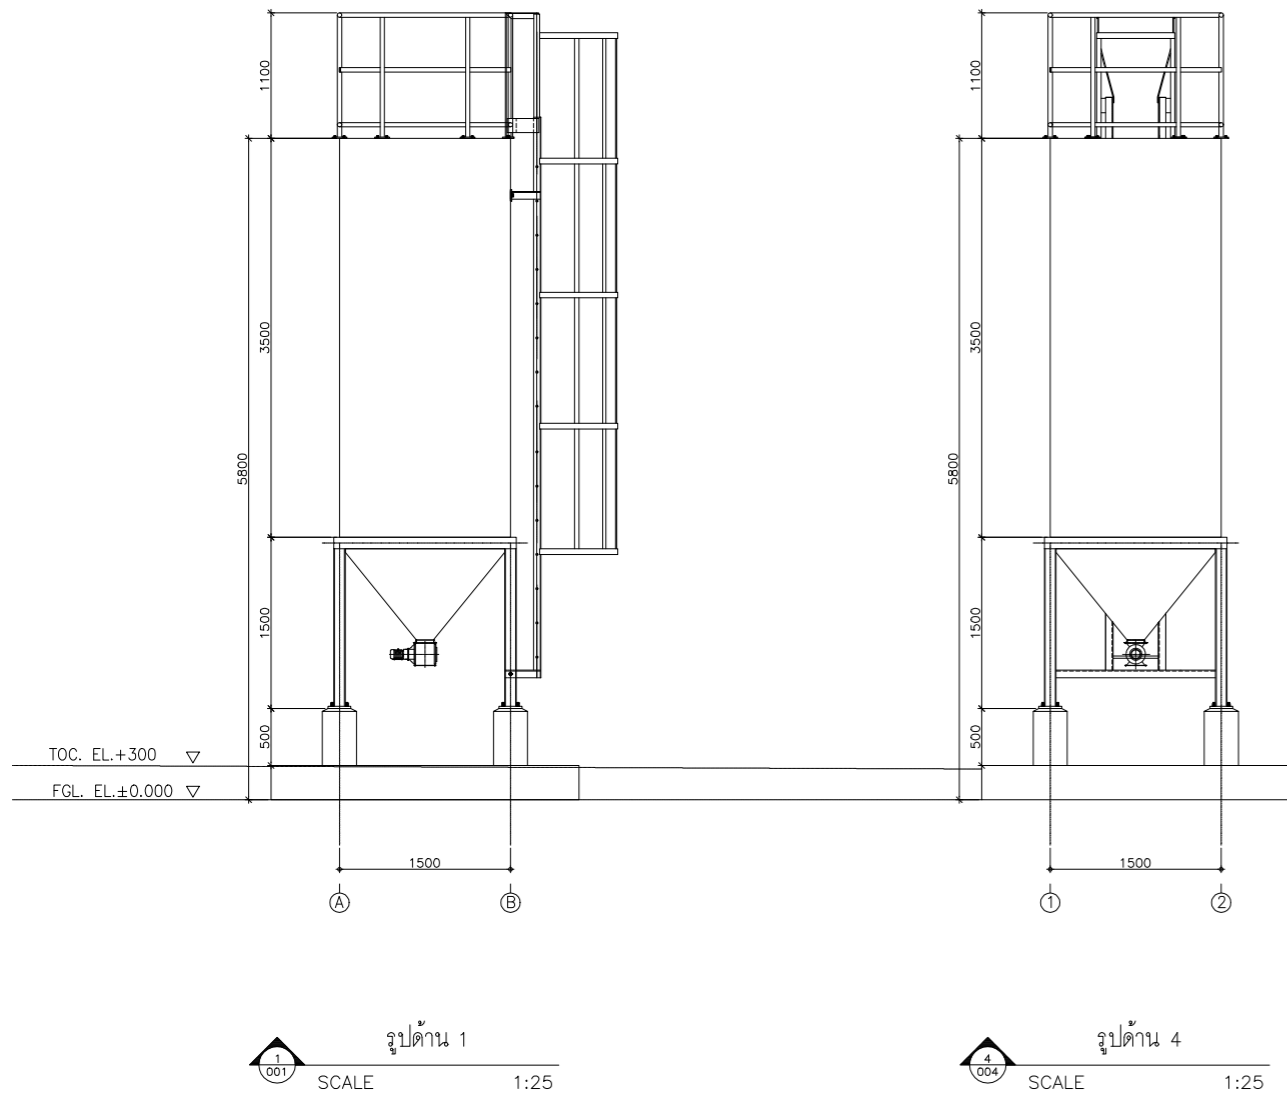

ตัวอย่างผลงานการออกแบบ เครื่องบำบัดมลพิษ(BAG FILTER)